




1/8" = 1'-0"



1/8" = 1'-0"

BM 350156-610740_Garrett_College_CEPAC56-1810740_garcepac_rj_2018.rvt
R20/2022 2:34:03 PM

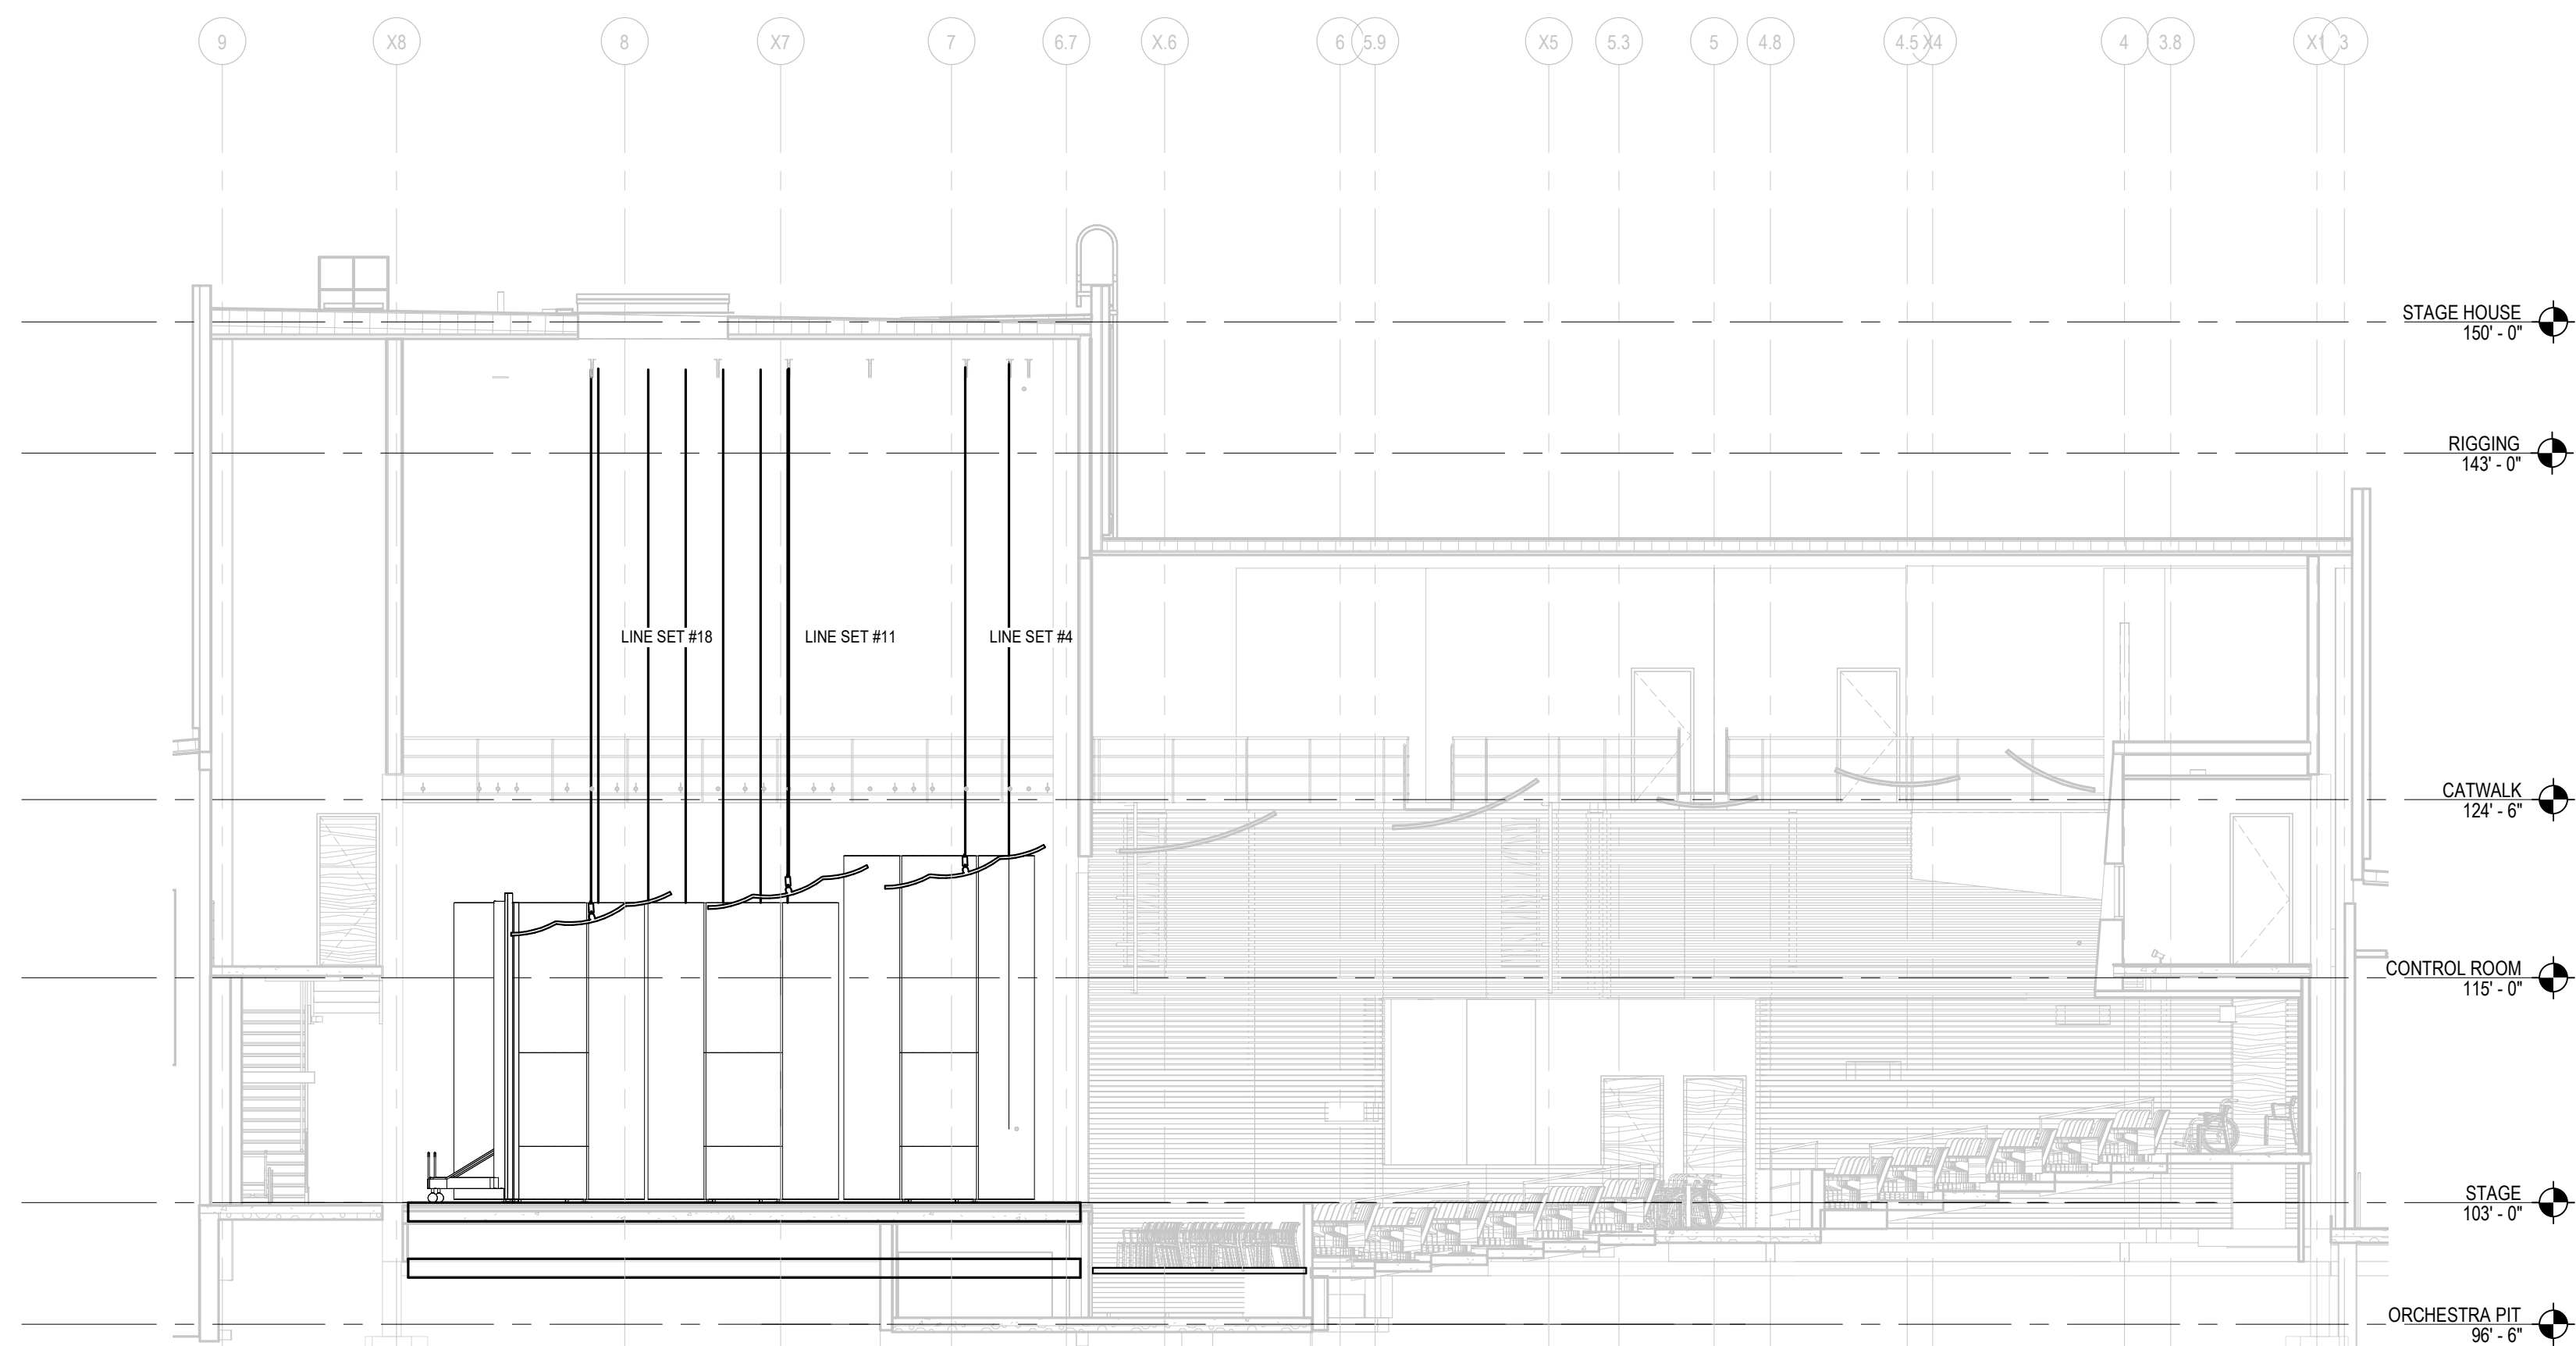

ACOUSTIC SHELL LONGITUDINAL SECTION
1/8" = 1'-0"

LEGEND NOTES



NOT FOR
CONSTRUCTION

GARRETT COLLEGE CEPAC

687 MOSSER ROAD,
MCHEERY, MD 21541

ORCHESTRA
SHELL BID
PACKAGE
Issue Date: 6/29/22
Revisions


56-18107-00
ACOUSTIC SHELL
LONGITUDINAL
SECTION

QT361

1

2

RIGGING SCHEDULE				
LINE SET	DISTANCE TO...	Suspension...	FUNCTION	LENGTH
1	1' - 8"	DEAD HUNG	VALANCE	58'
2	2' - 8"	HOIST	MAIN CURTAIN	58'
3	3' - 8"	HOIST	FIRST ELECTRIC/GENERAL USE	58'
4	6' - 0"	HOIST	ACOUSTIC CEILING #1	58'
5	7' - 10"	DEAD HUNG	GENERAL USE	58'
6	8' - 10"	DEAD HUNG	FIRST BORDER	58'
7	9' - 10"	DEAD HUNG	FIRST LEG SET	58'
8	11' - 2"	HOIST	SECOND ELECTRIC/GENERAL USE	58'
9	12' - 2"	DEAD HUNG	GENERAL USE	58'
10	13' - 2"	DEAD HUNG	GENERAL USE	58'
11	15' - 6"	HOIST	ACOUSTIC CEILING #2	58'
12	16' - 10"	DEAD HUNG	SECOND BORDER	58'
13	17' - 10"	DEAD HUNG	MID-STAGE TRAVELER	58'
14	19' - 2"	HOIST	THIRD ELECTRIC/GENERAL USE	58'
15	21' - 2"	DEAD HUNG	GENERAL USE	58'
16	23' - 8"	DEAD HUNG	THIRD BORDER	58'
17	24' - 8"	DEAD HUNG	THIRD LEG SET	58'
18	26' - 0"	HOIST	ACOUSTIC CEILING #3	58'
19	27' - 4"	DEAD HUNG	FOURTH ELECTRIC/GENERAL USE	58'
20	30' - 0"	DEAD HUNG	FOURTH BORDER	58'
21	31' - 0"	DEAD HUNG	SHARKSTOOTH SCRIM	58'
22	32' - 0"	DEAD HUNG	FIFTH ELECTRIC/GENERAL USE	58'
23	35' - 0"	DEAD HUNG	CYC	58'

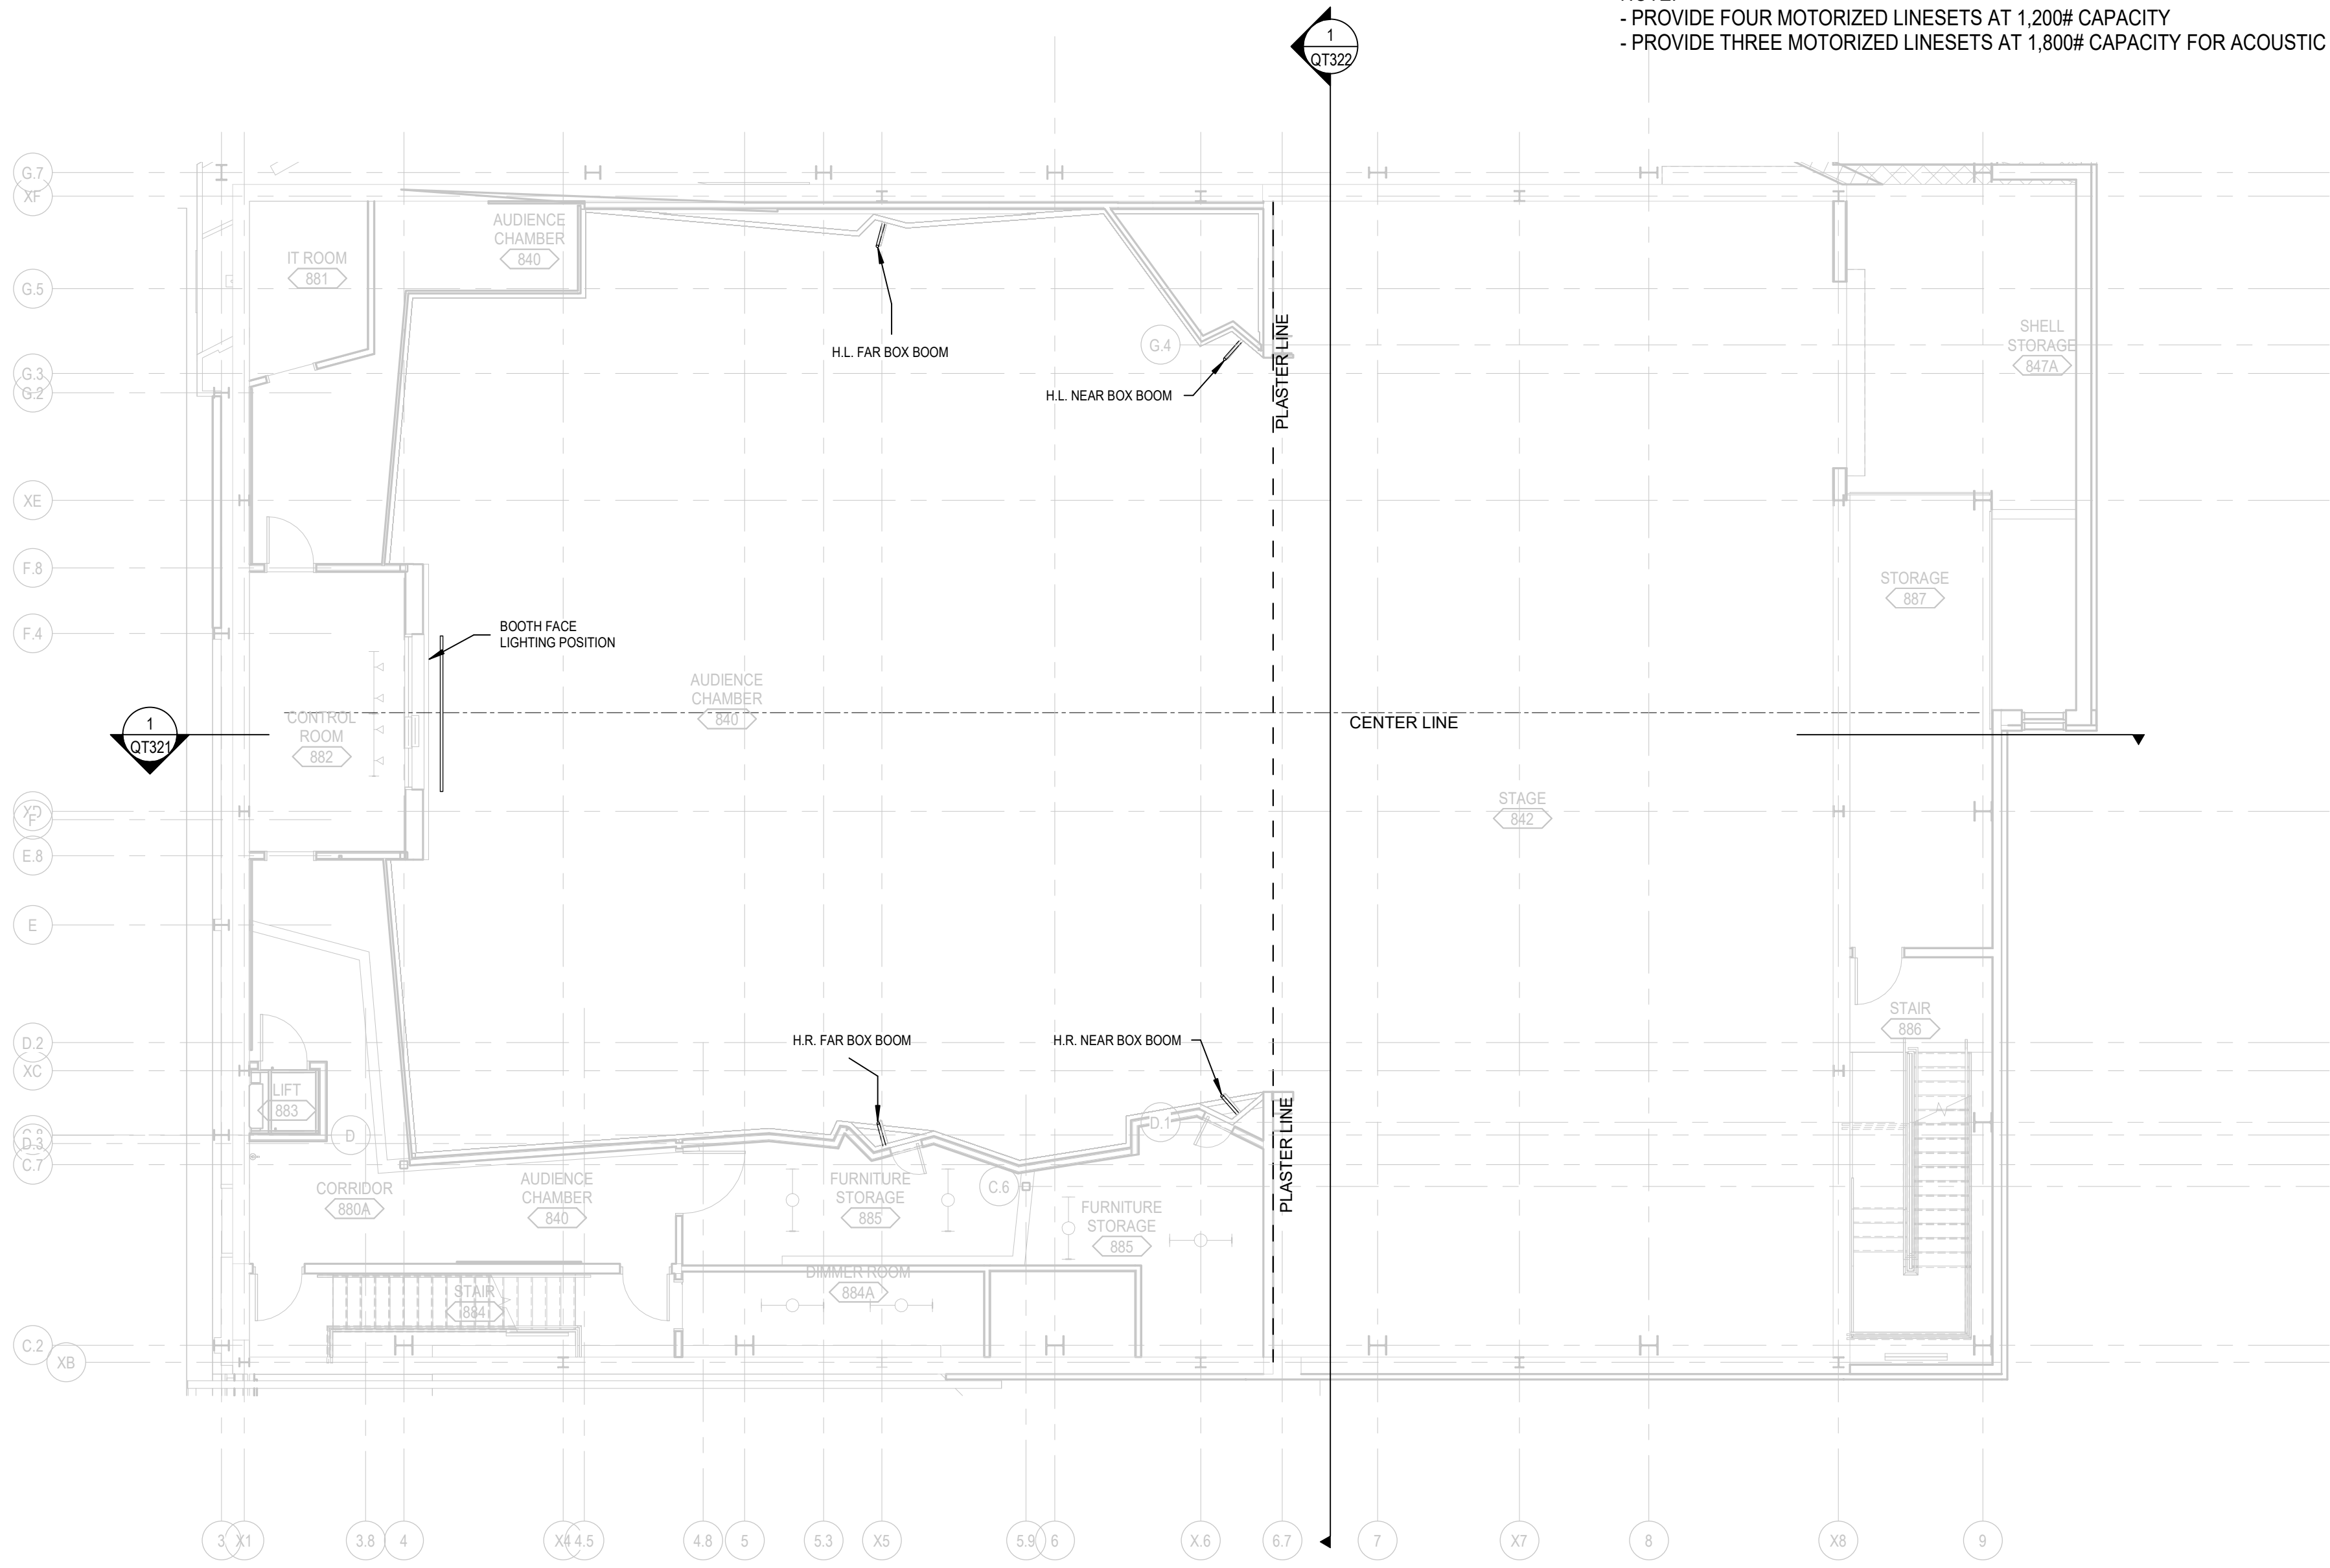

THEATRICAL RIGGING PLAN, CONTROL ROOM LEVEL PLAN

1/8" = 1'-0"



THEATRICAL RIGGING PLAN, STAGE LEVEL


1/8" = 1'-0"

LEGEND NOTES



THEATRICAL RIGGING, CATWALK LEVEL
1/8" = 1'-0"

BM 320156- 6/17/20_Garrett_College_CEPAC06-18/17-20_garret_col_2018.rvt
R3/2020 5:07:51 PM

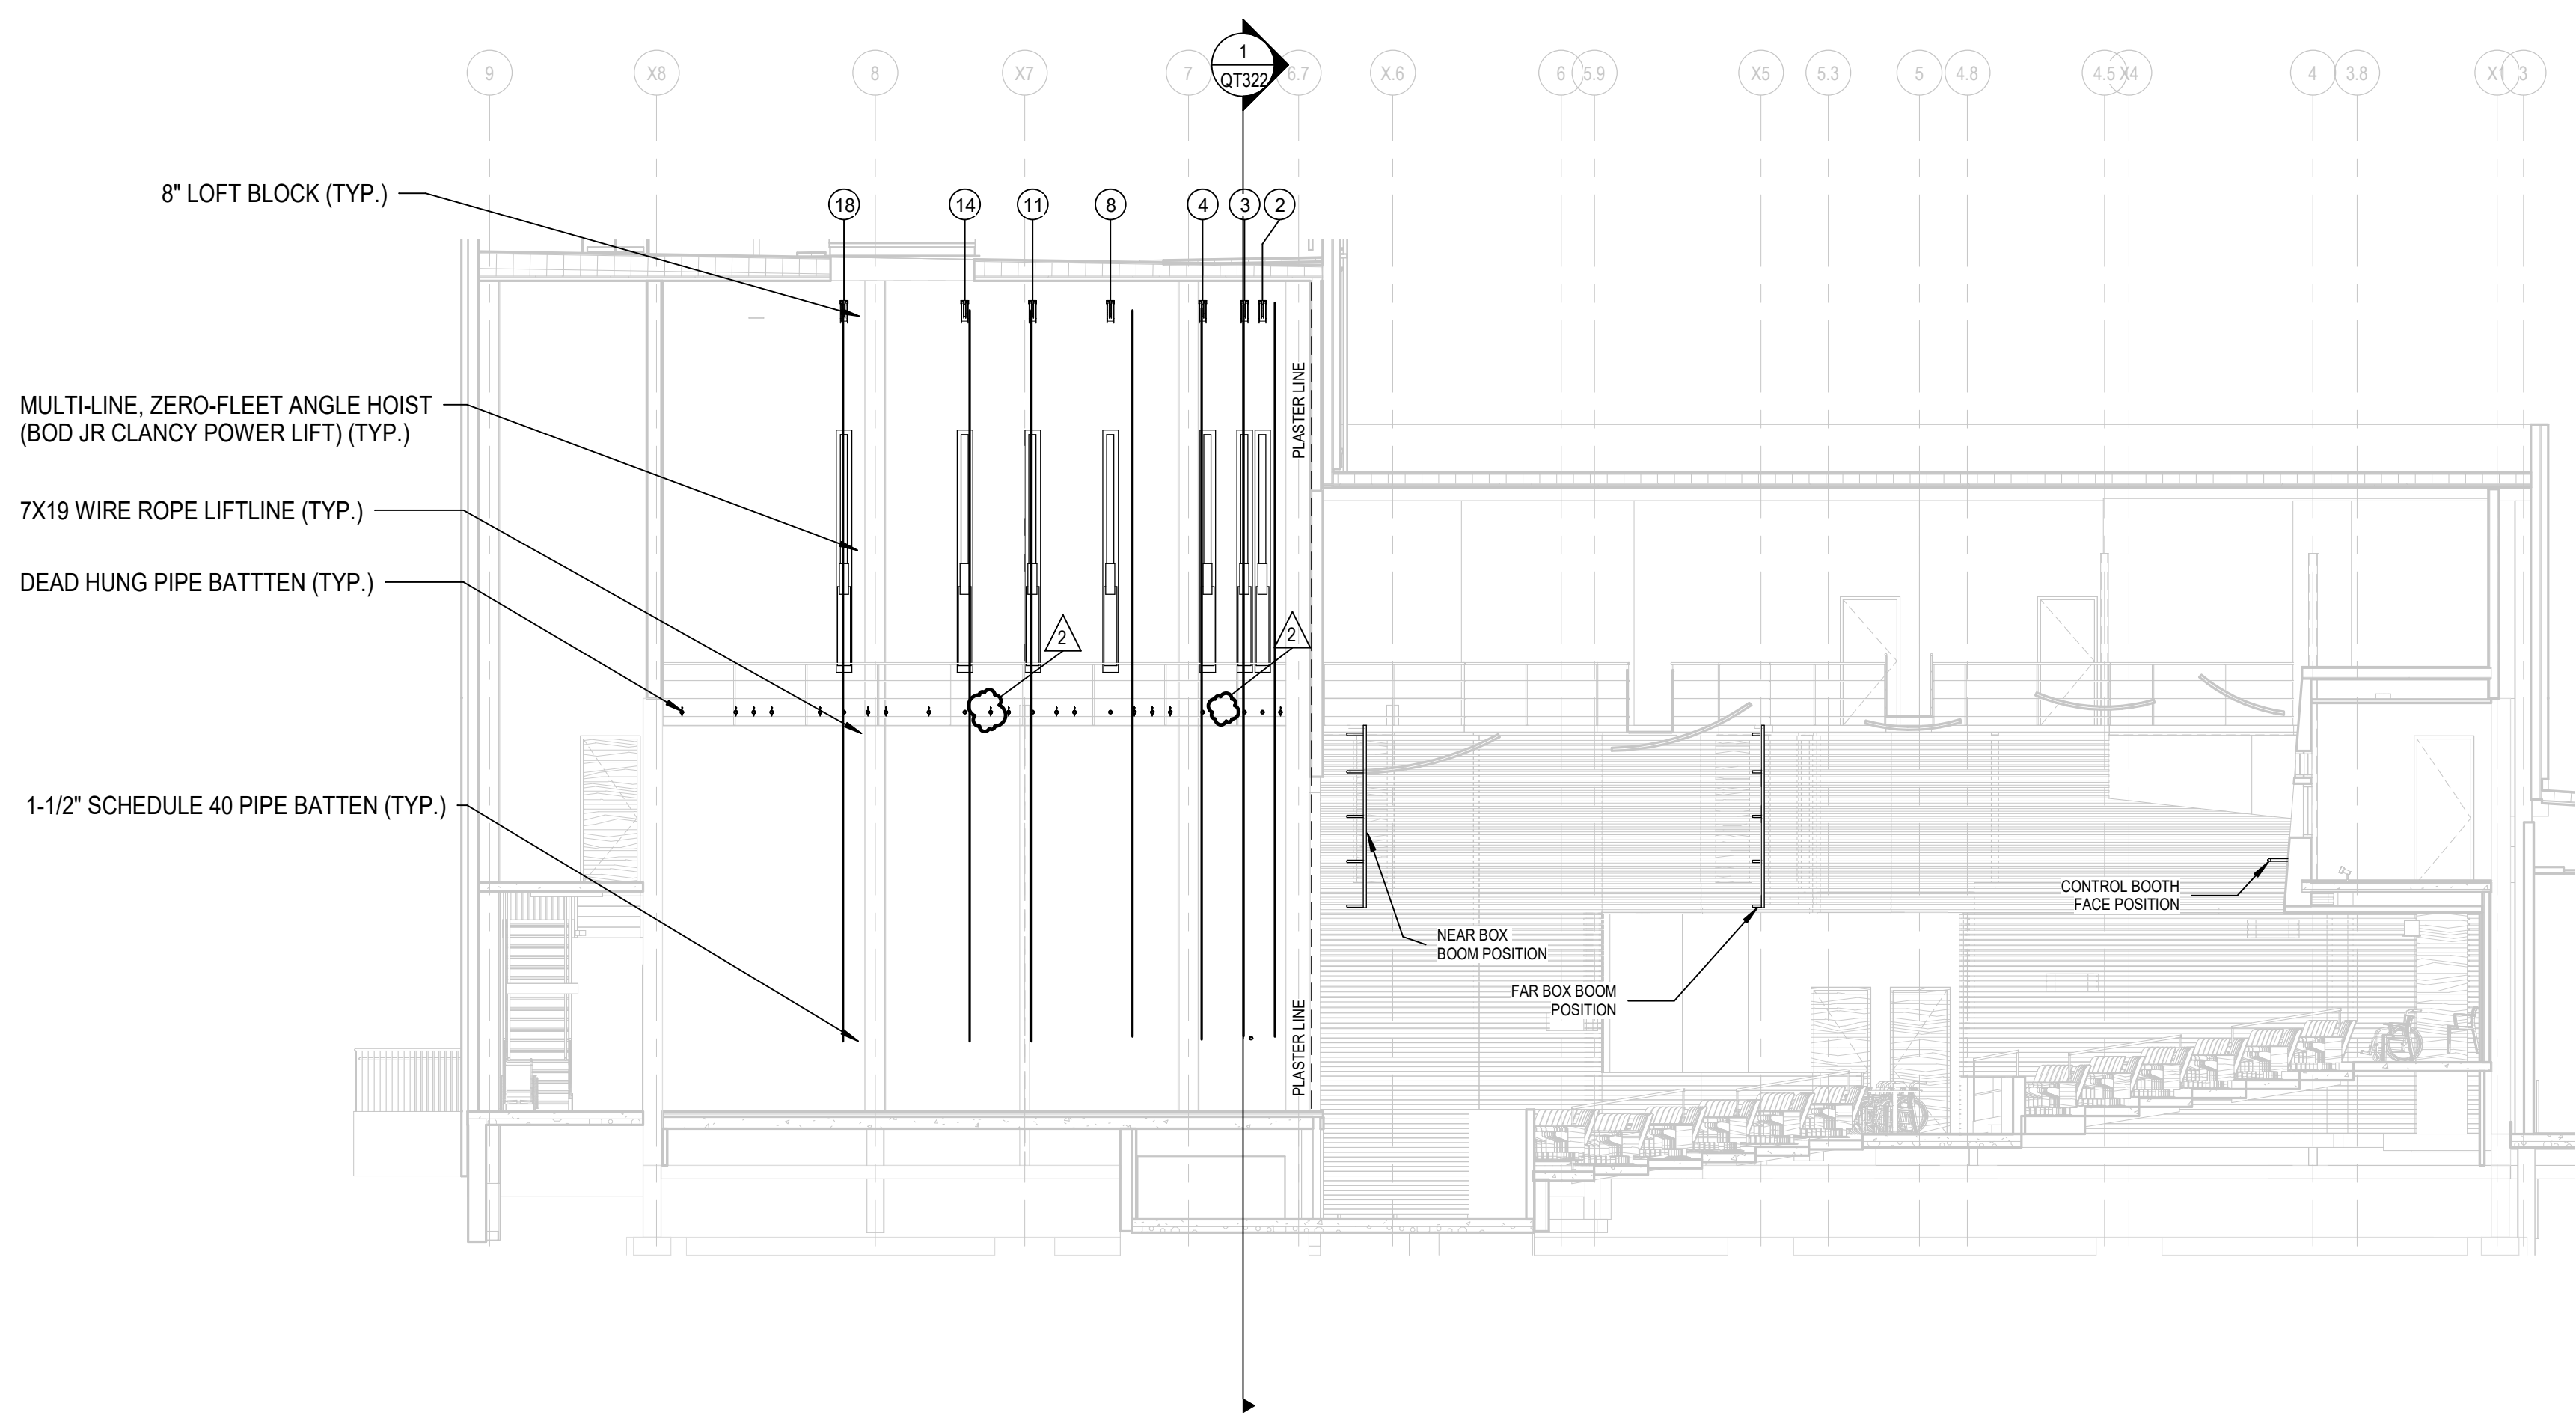

PROSCENIUM THEATRE LONGITUDINAL
SECTION
1/8" = 1'-0"

LEGEND NOTES



GARRETT COLLEGE CEPAC

687 MOSSER ROAD,
MCHEENY, MD 21541


ISSUED FOR BID
AND PERMIT

Issue Date: 11/15/2019
Revisions
2 ASI 01 42/120

56-18107-00
THEATRICAL
RIGGING
LONGITUDINAL
SECTION

QT321


BM 350/356-610740_Garrett_College_CEPAC56-1810740_gar-acas.ctb 2018.rvt
R3/2020 5:07:53 PM

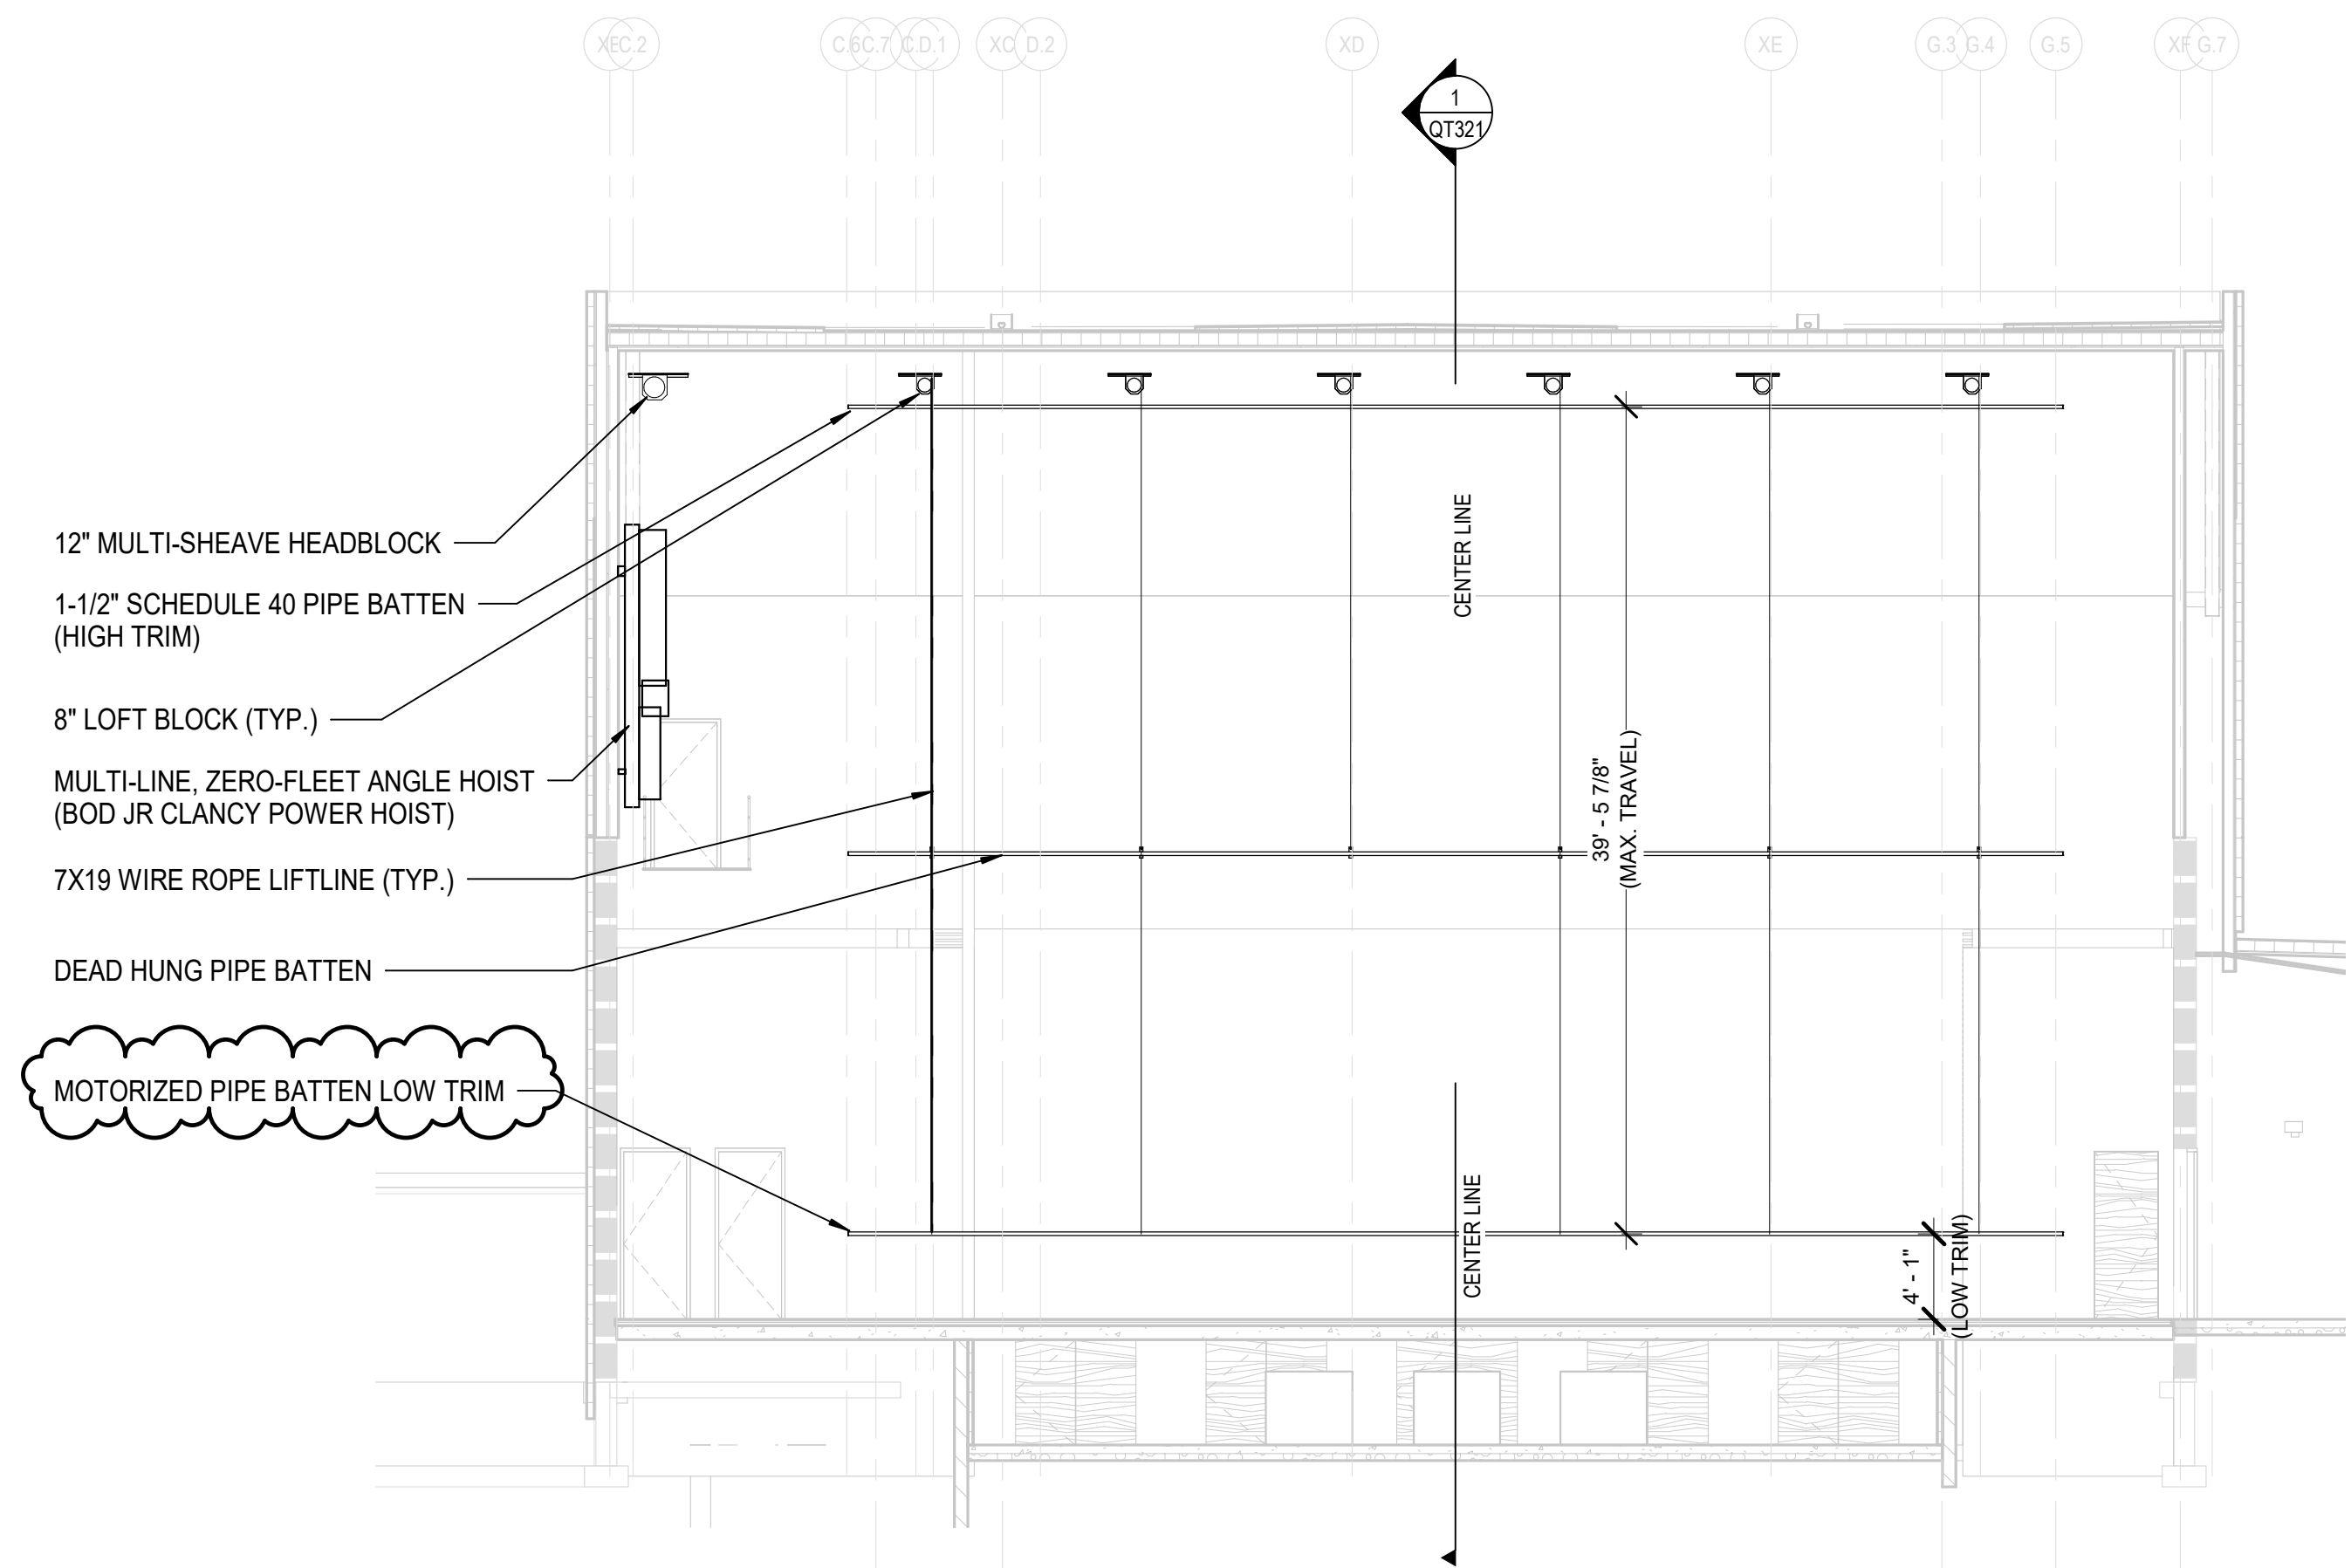


PROSCENIUM THEATER TRANSVERSE
SECTION
1/8" = 1'-0"

LEGEND NOTES


BM 350/356-6107-00_Garrett_College_CEPAC056-18107-00_gcc-cepac_dtl_2018.rvt
R3/2020 5:08:29 PM

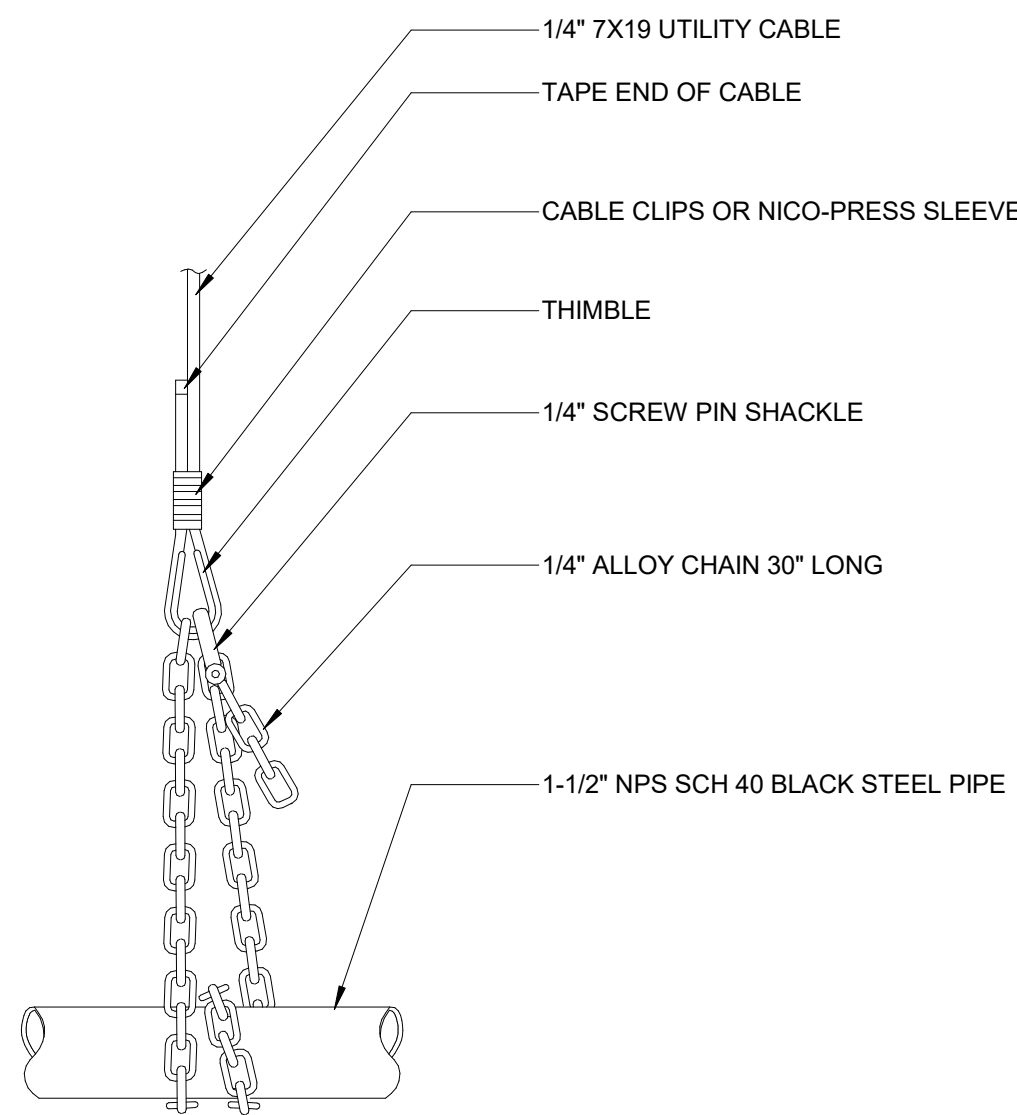


TYP. TRIM CHAIN DETAIL
3" = 1'-0"

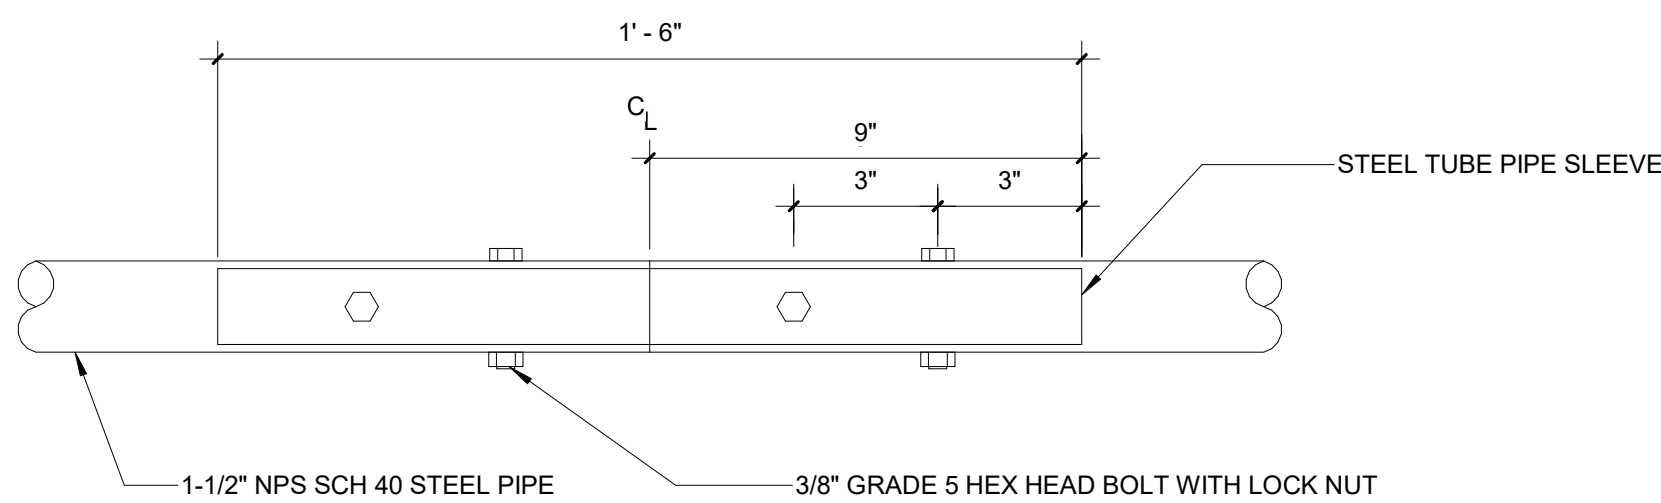

TYPICAL PIPE SLEEVE DETAIL2
3" = 1'-0"

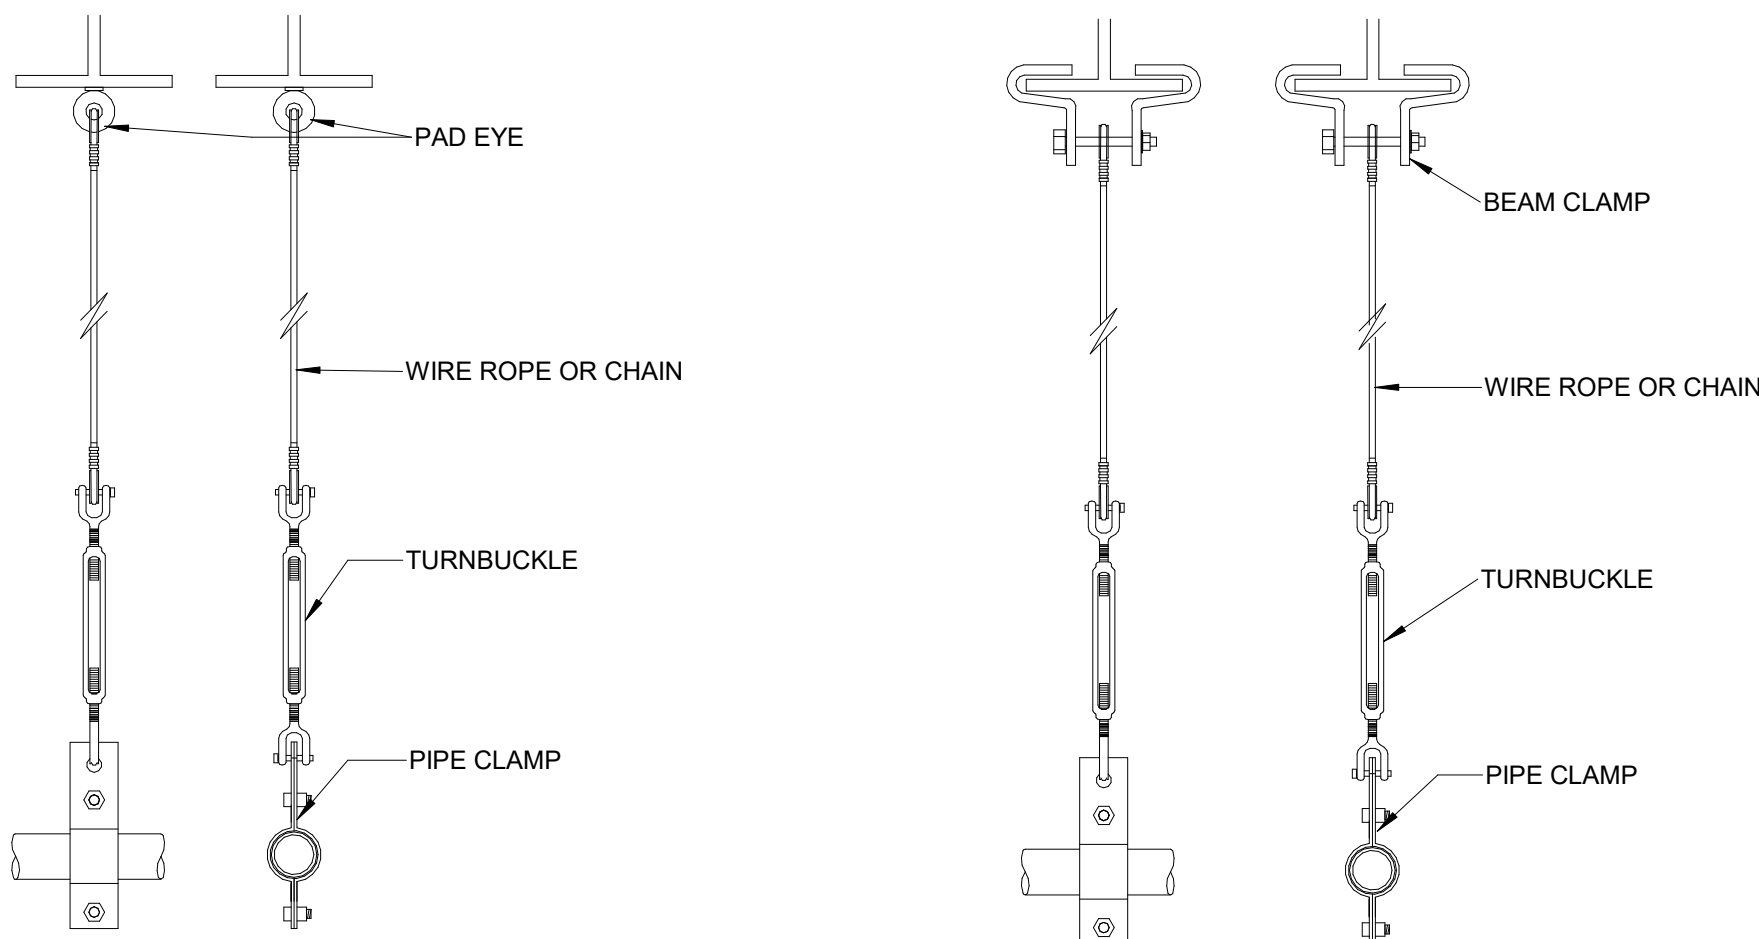


TYP. PIPE GRID MOUNTING
1 1/2" = 1'-0"

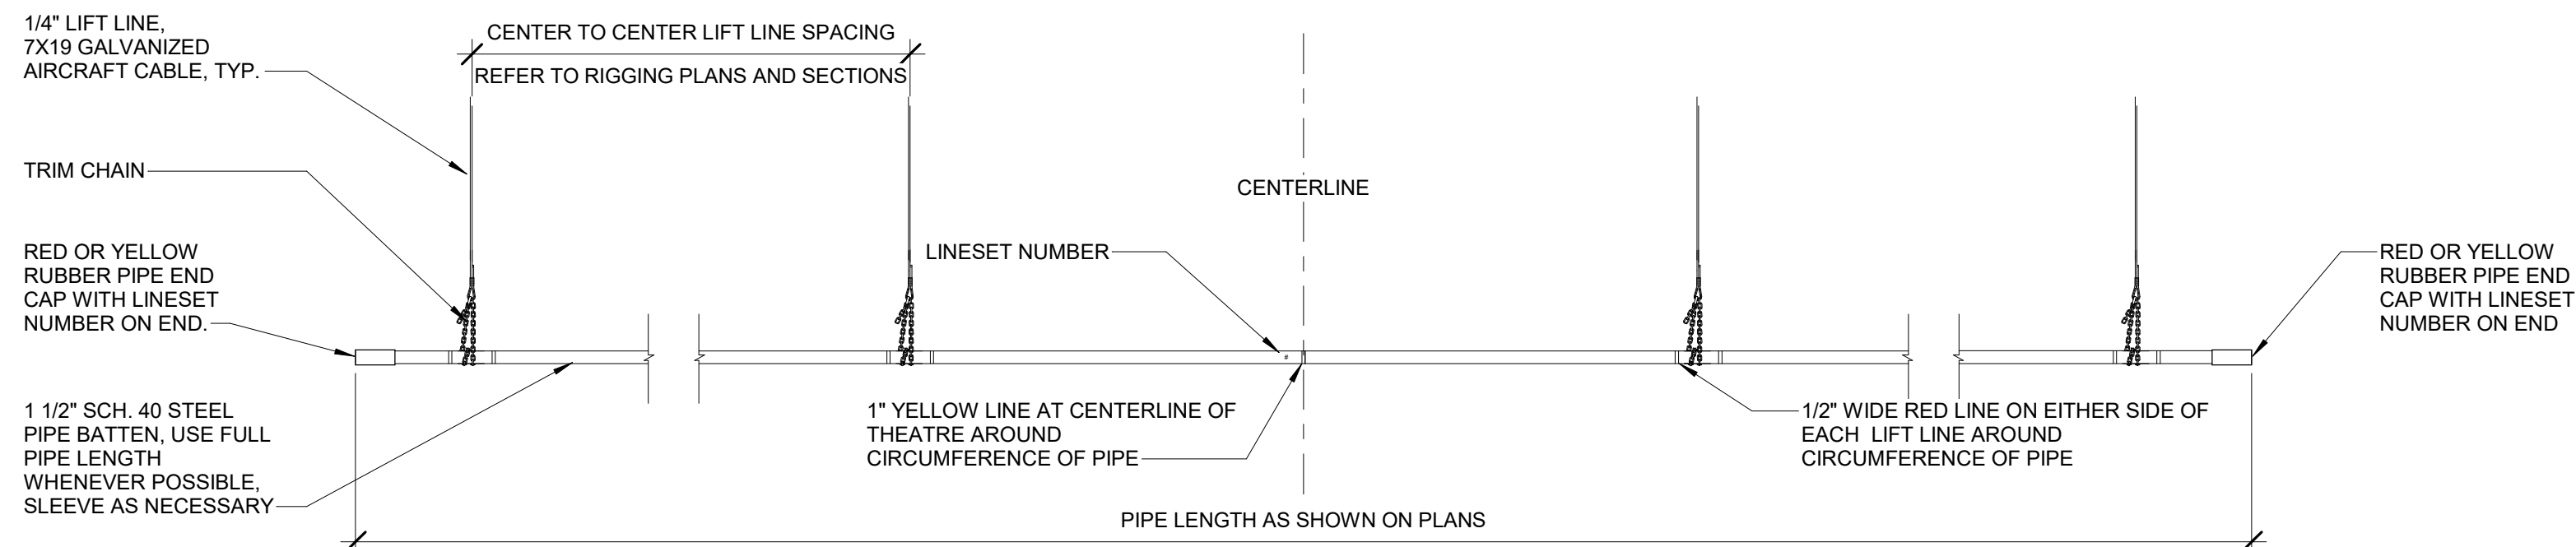


NOTE:
- SPLICE AS NECESSARY, PER DETAIL ON THIS SHEET, TO ACHIEVE LENGTH.
- DRILL ALL PIPES TO ACCEPT EXTENSION PIPES.
- DRILL ALL PIPES SUCH THAT COMPONENTS ARE INTERCHANGEABLE.


TYPICAL PIPE BATTEN DETAIL1
1/2" = 1'-0"

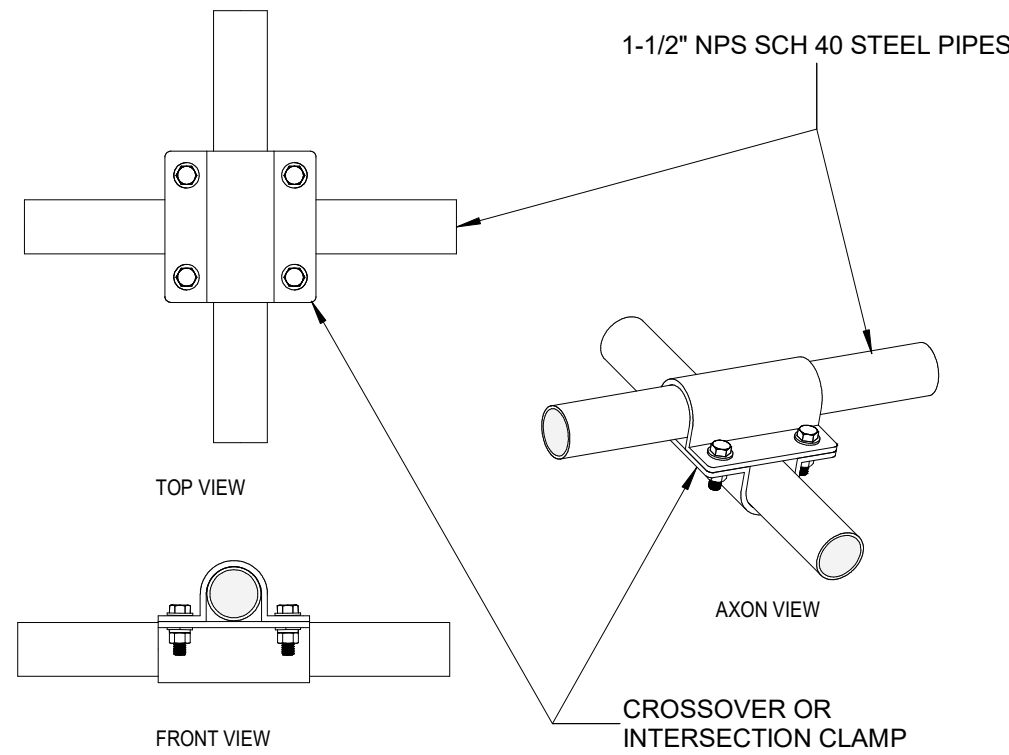


CROSS GRID CONNECTOR
1 1/2" = 1'-0"

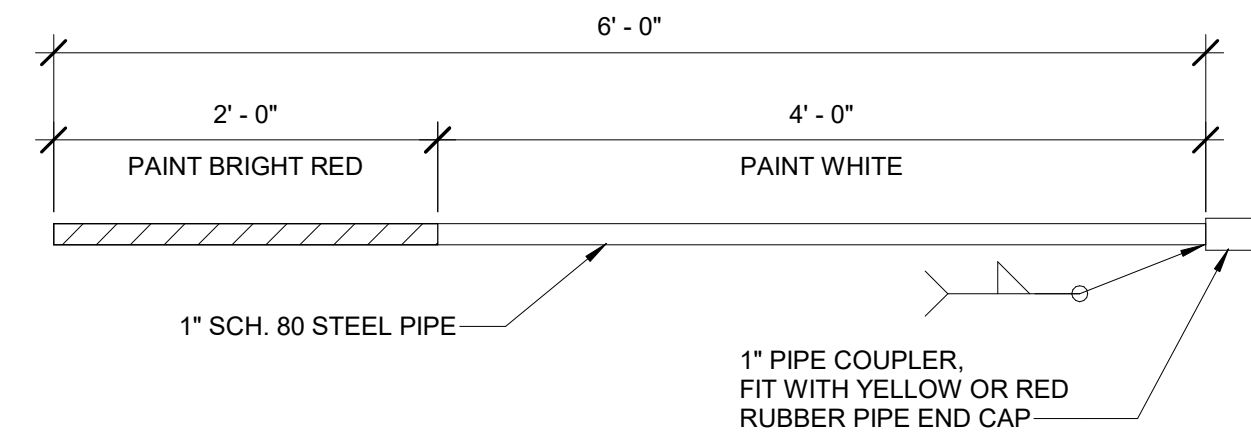


TYP. PIPE EXTENSION DETAIL1
1" = 1'-0"

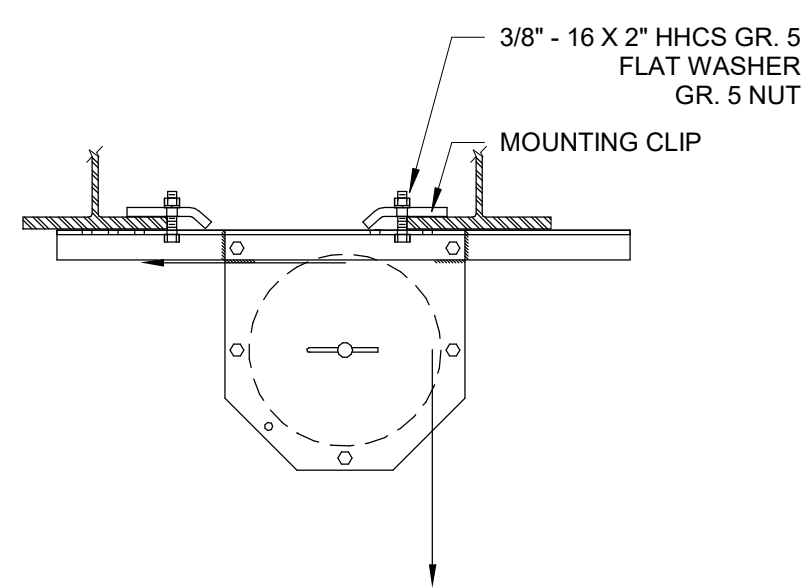


LOFT BLOCK ATTACHMENT
1 1/2" = 1'-0"

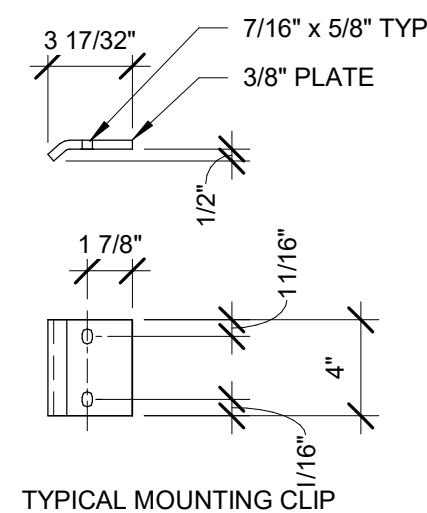

TYPICAL MOUNTING CLIP

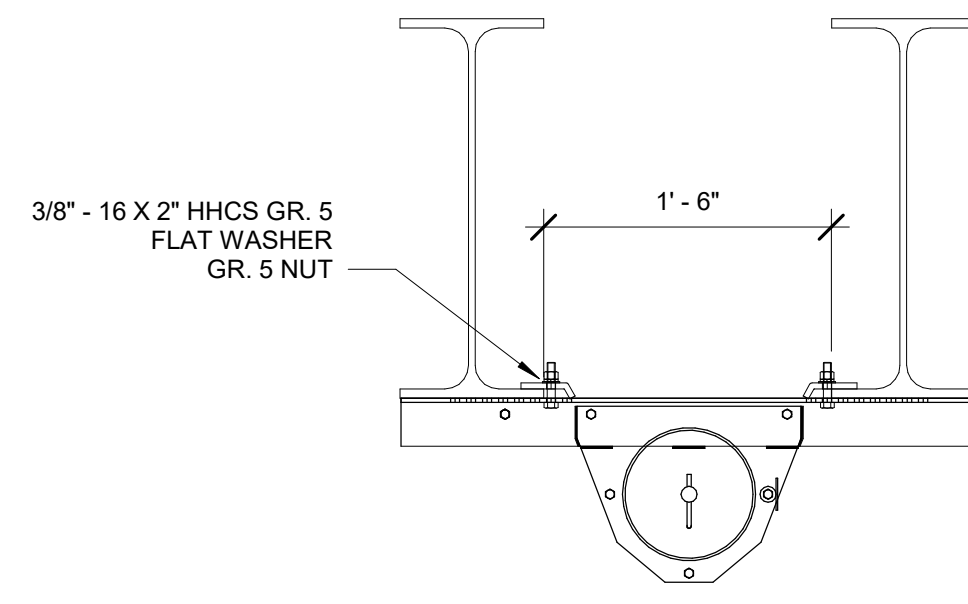

TYPICAL HEAD BLOCK MOUNTING

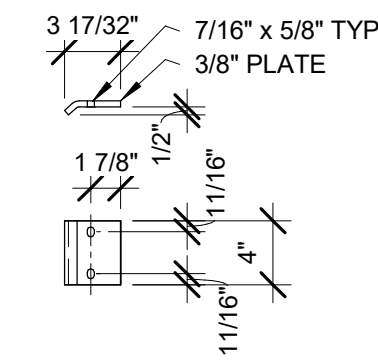


TYPICAL MOUNTING CLIP

HEAD BLOCK ATTACHMENT1
1" = 1'-0"

LEGEND NOTES

BN 320/186-6107-00_Garrett_College_CEPAC06-18107-00_GCCFAC_AR_2018.rvt
4/12/2021 10:27:47 AM

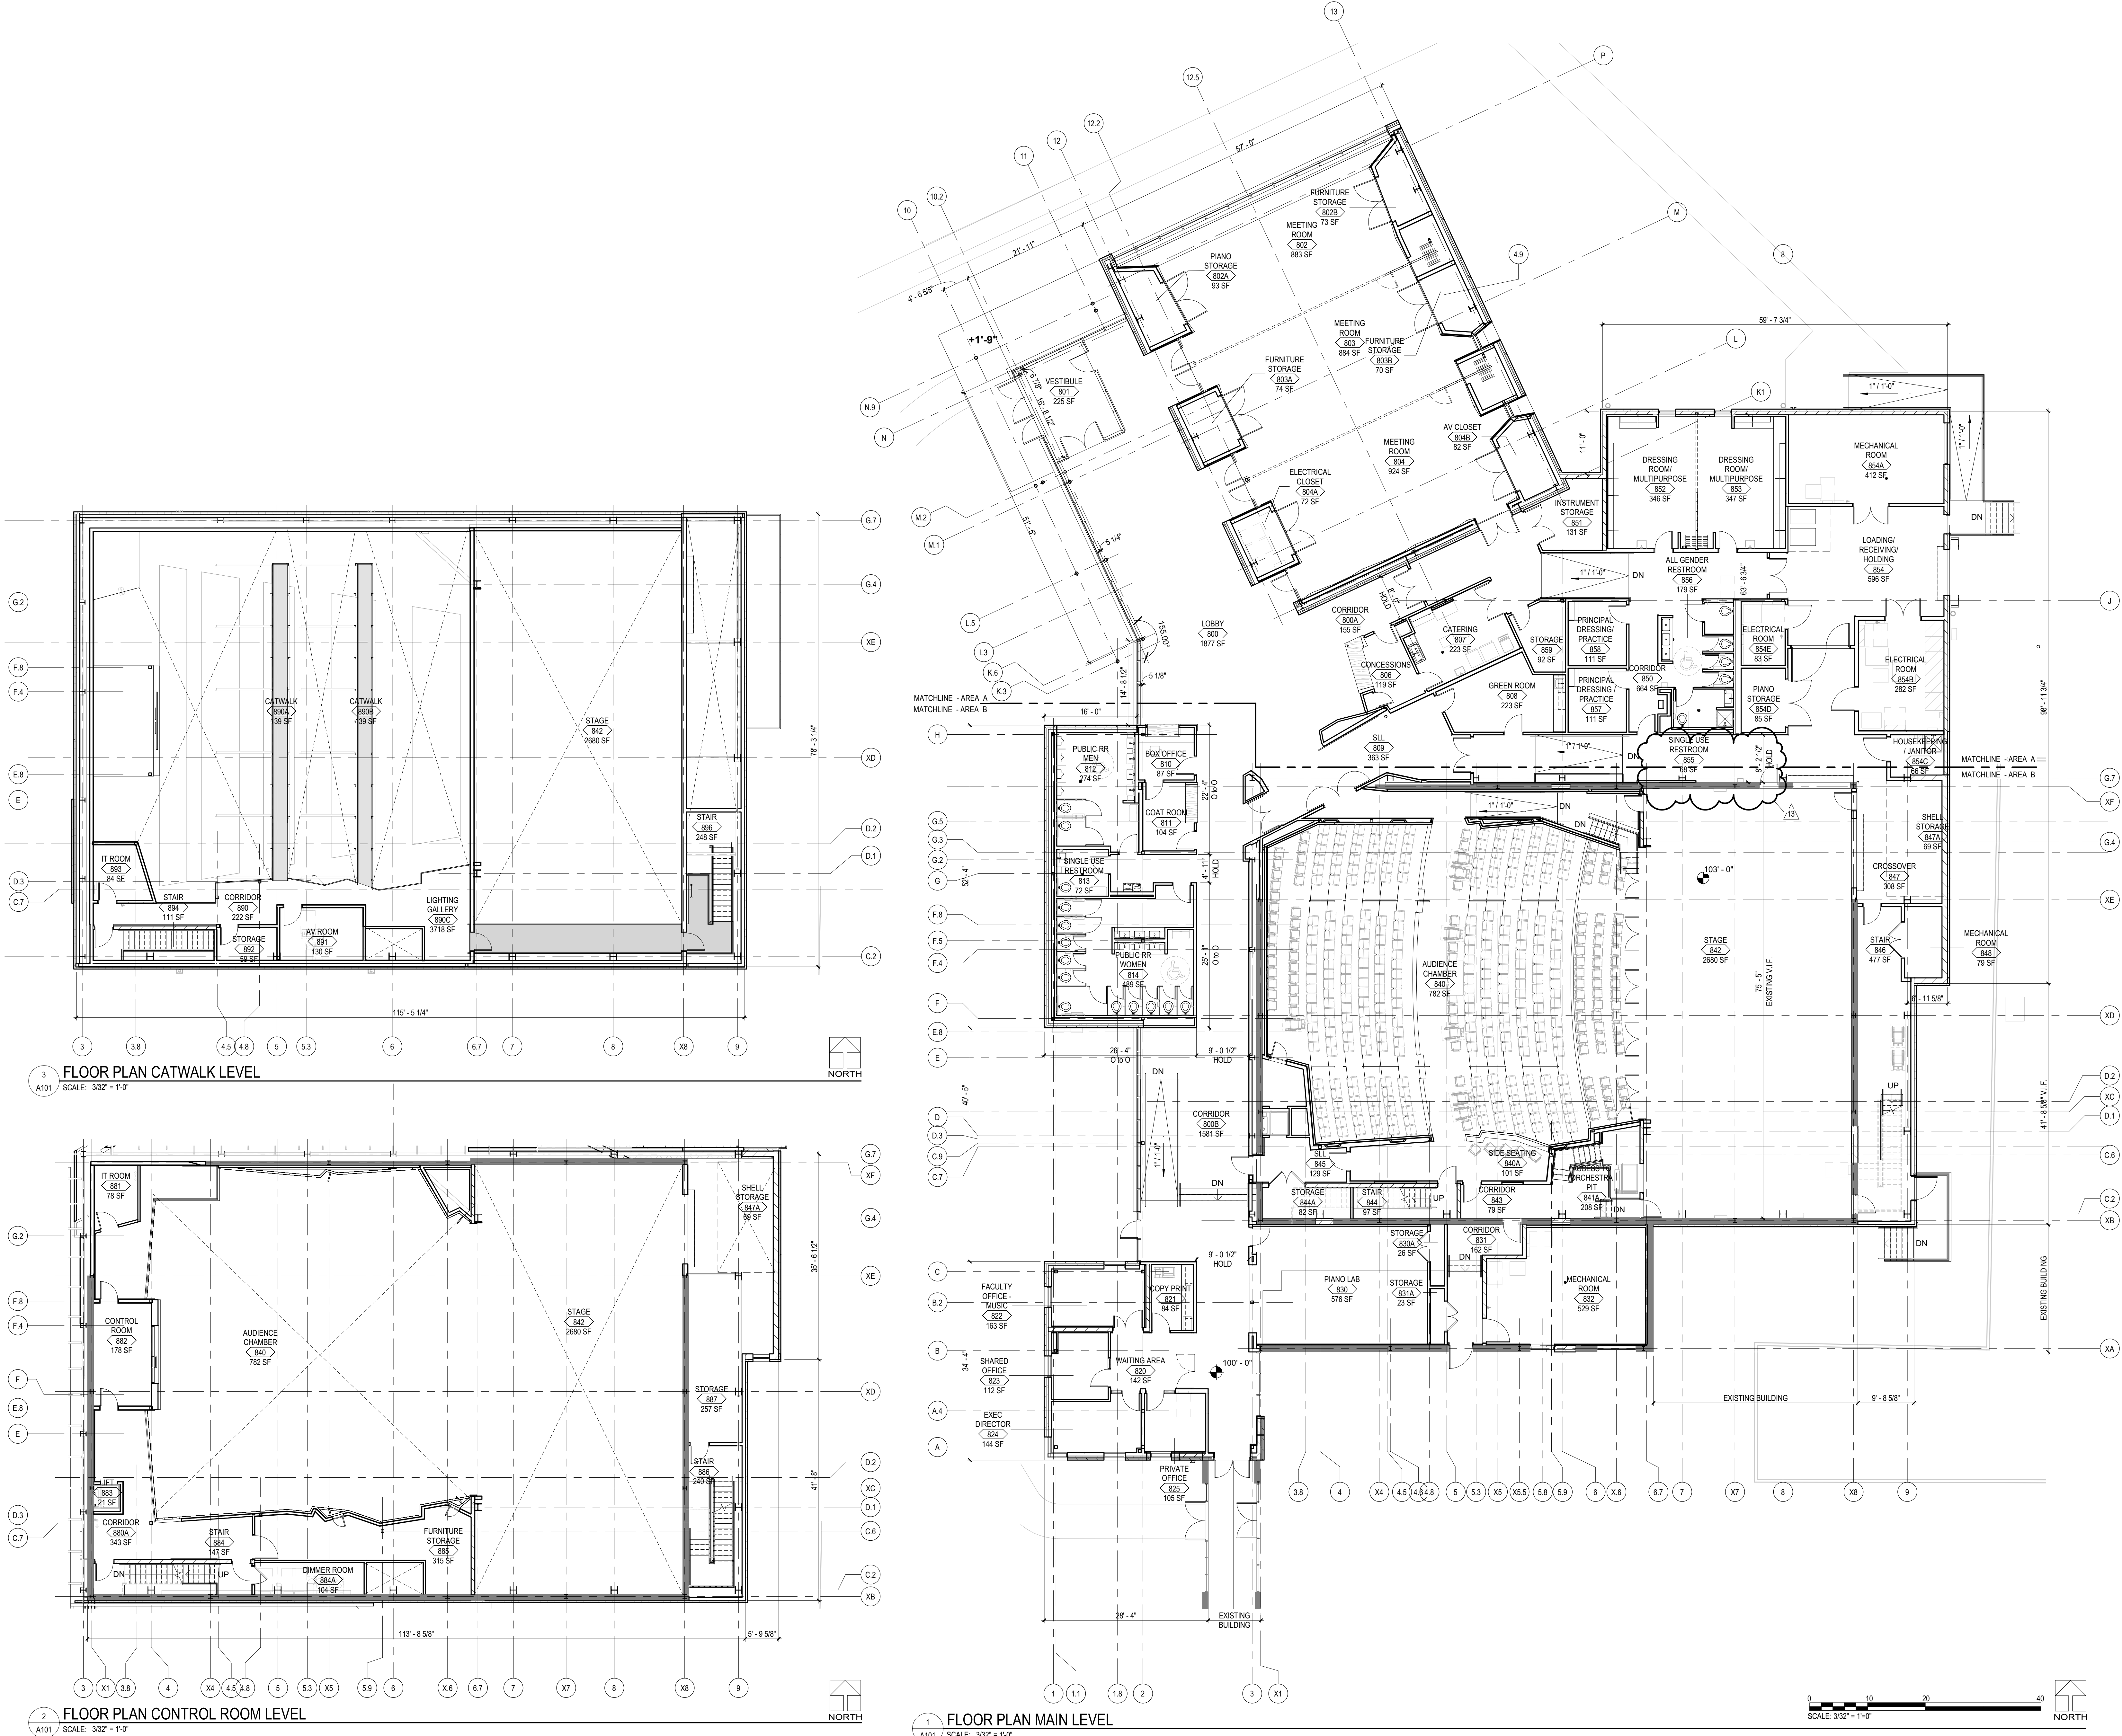

LEGEND NOTES


General Notes - Floor Plan

1. NOT USED
2. SEE A-800 FOR DOOR TYPES AND SCHEDULE
3. ALL DIMENSIONS ARE FROM STUD TO STUD, OR TO COLUMN CENTERLINE, OR FACE OF MASONRY UNLESS NOTED OTHERWISE. ALL THICKNESSES ARE NOMINAL DIMENSIONS.
4. ALL DOOR OPENINGS ARE DIMENSIONED TO SCHEDULE DOOR OPENINGS
5. VERIFY ALL DIMENSIONS AND CONDITIONS IN THE FIELD
6. REFER TO ALL DISCIPLINE DRAWINGS FOR FULL EXTENT OF WORK. COORDINATE BETWEEN ALL TRADES / DISCIPLINES
7. FLOOR TOLERANCE: EXISTING FLOOR SLABS TO BE LEVELED TO A TOLERANCE OF 1/4" IN 10'-0"
8. ALL SLABS ABOVE 0'-0" TO BE BUILT OVER EXISTING SLAB AND STRUCTURAL FILL


Floor Plan Legend

- EXISTING WALL
- NEW WALL
- NEW MASONRY WALL
- FINISH FURRING OVER DRYWALL PARTITIONS
- KEYED NOTE
- WALL TYPE TAG
- CORNERGUARD - SEE INTERIOR DETAIL SHEETS
- NEW MILLWORK
- NEW DOOR
- EXISTING DOOR TO REMAIN
- KEYED NOTE
- SLAB PENETRATION, SEE PLUMBING DWGS
- FLOOR DRAIN, SEE PLUMBING DWGS
- CLEAN OUT, SEE PLUMBING DWGS

KEY PLAN

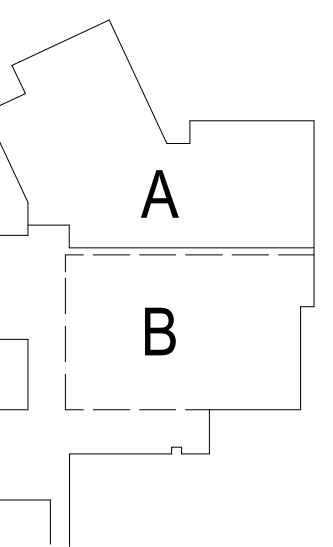



BN 320/166-1617-40_Garrett_College_CEPAC-1617-40_GCC-CEPAC_AR_2016.rvt
4/12/2021 10:27:50 AM

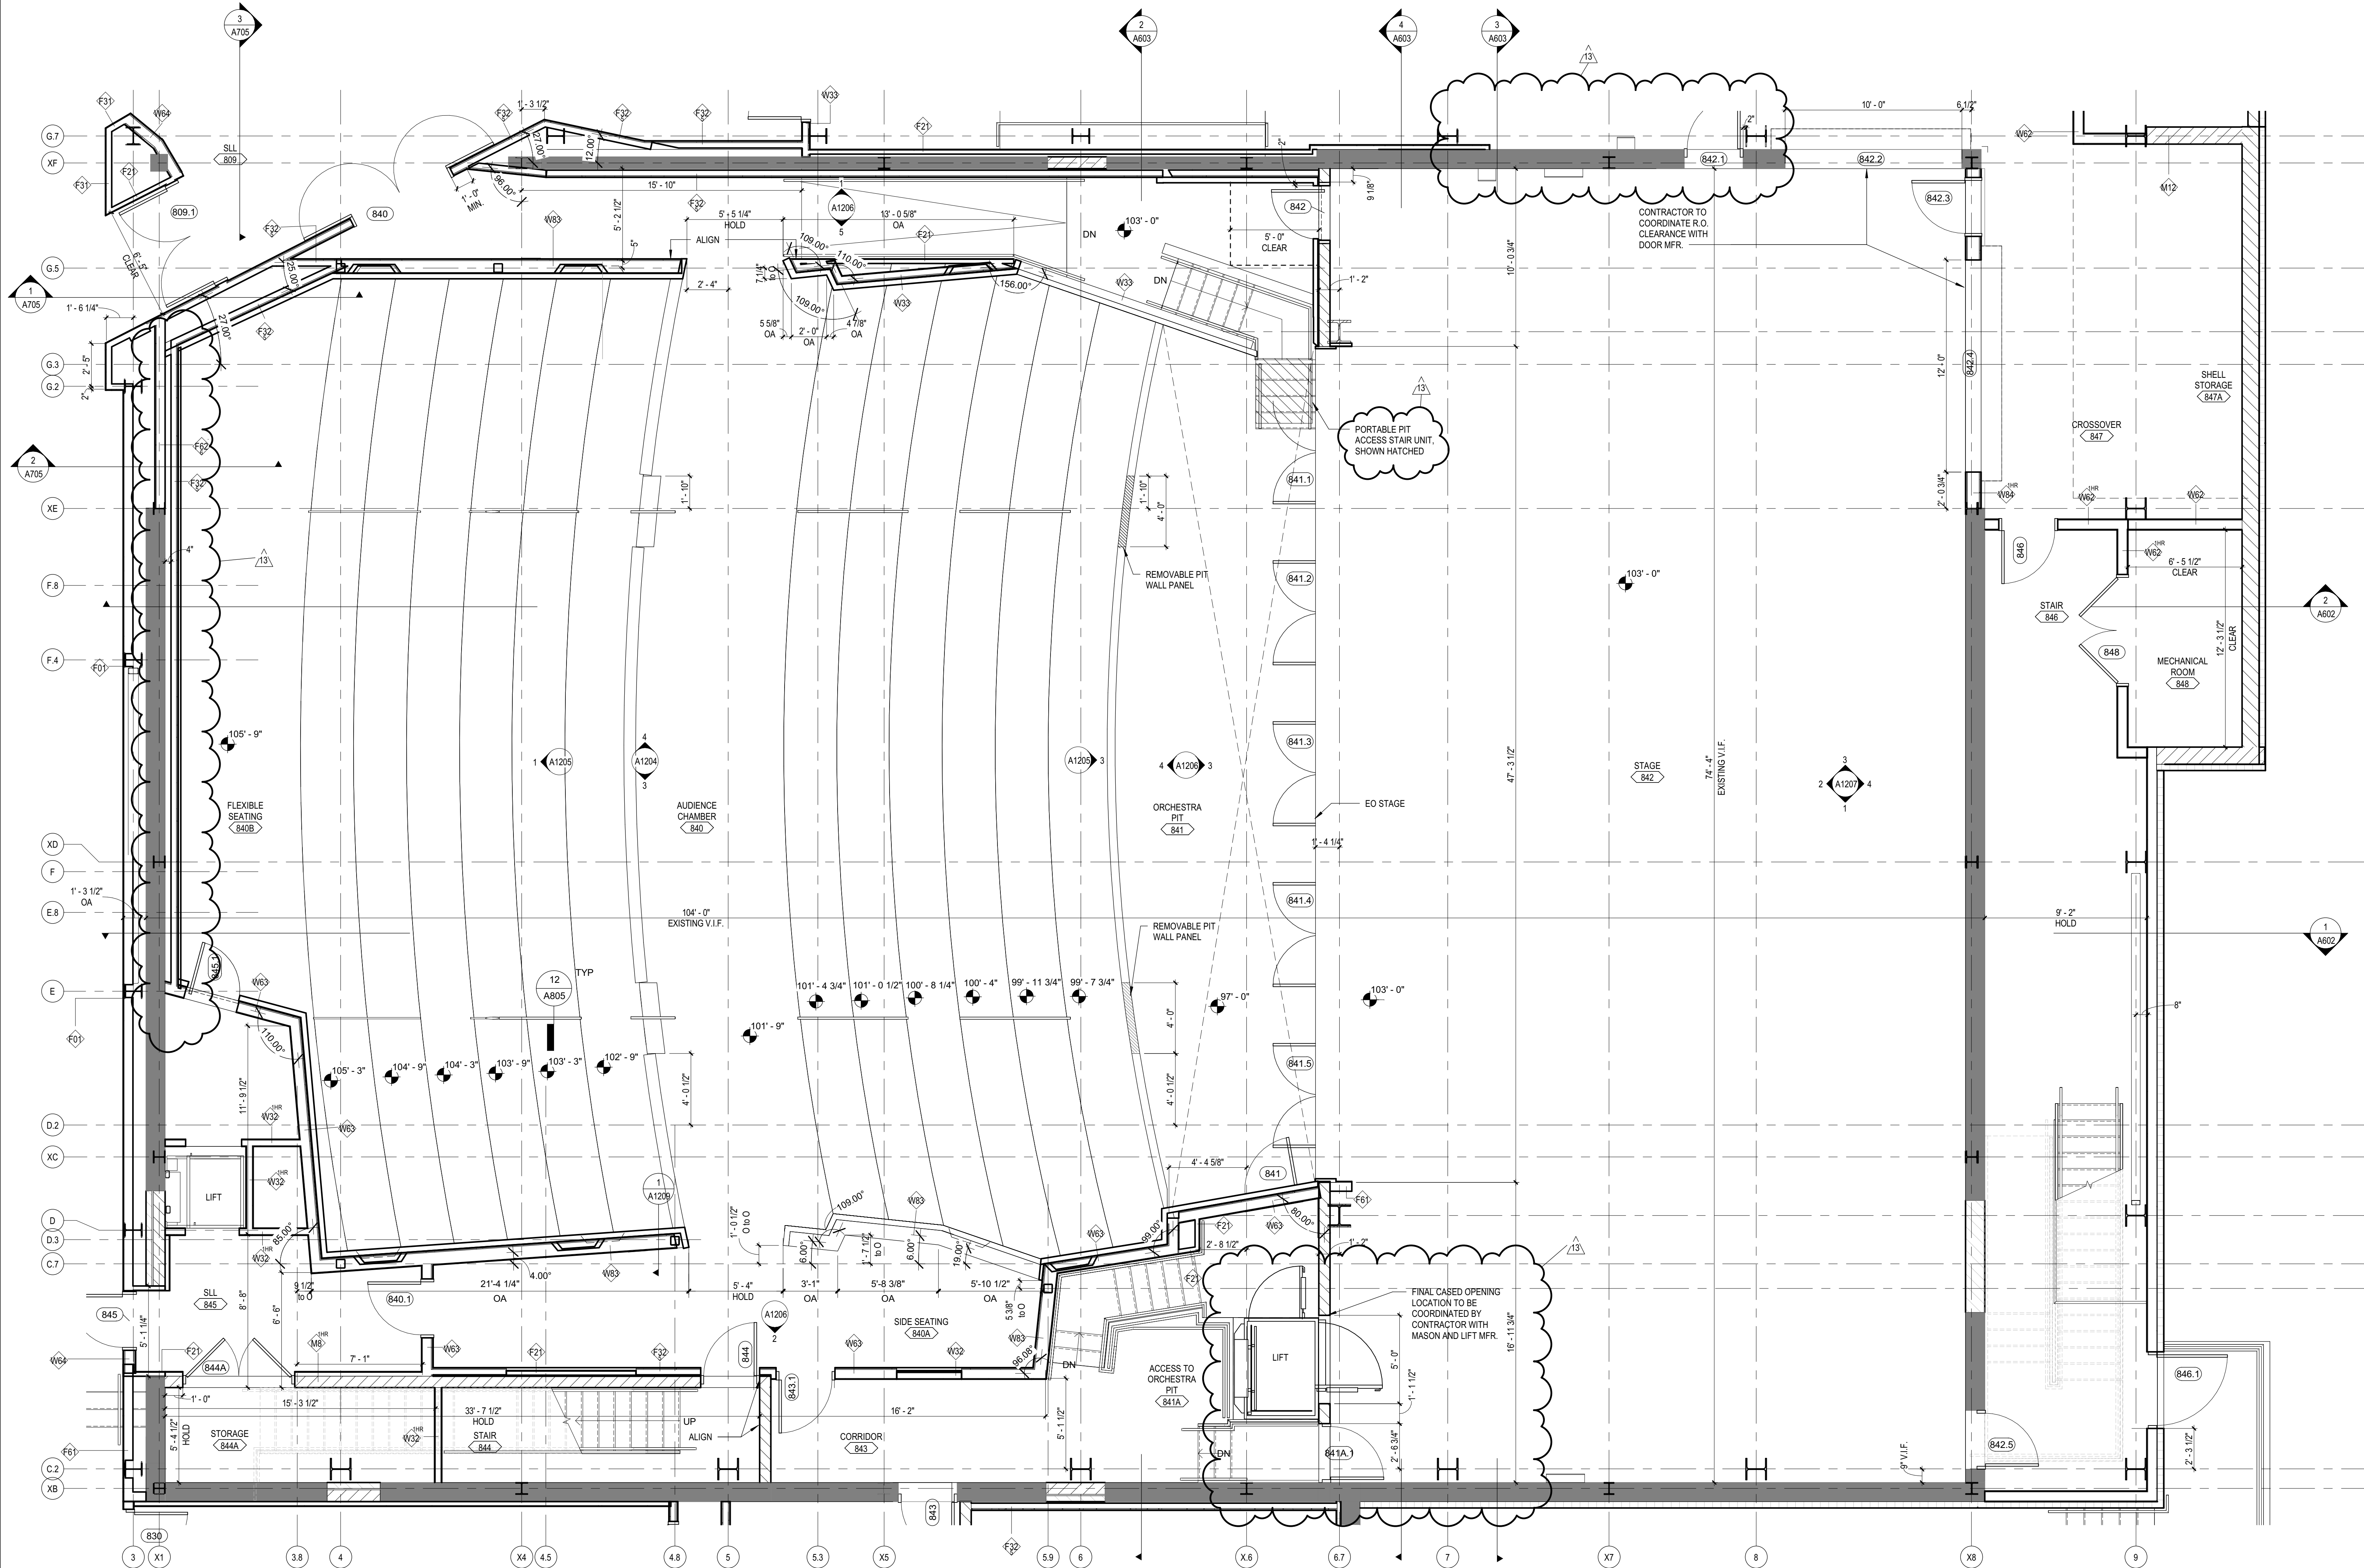

1
A201
ENLARGED FLOOR PLAN - MAIN LEVEL - THEATER
SCALE: 1/4" = 1'-0"

LEGEND NOTES

KEY PLAN

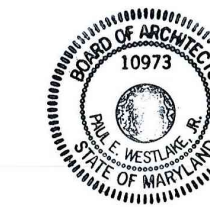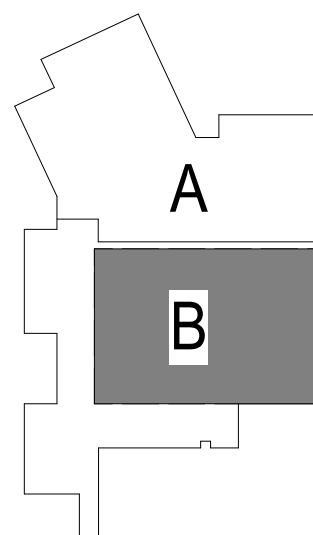

April 09, 2021
Professional Engineer, Maryland
These documents were prepared or
approved by me, and that I am a duly
licensed professional engineer in the
State of Maryland. License number
00075, expiration date 01-08-2027

ISSUED FOR BID
AND PERMIT

Issue Date: 11/15/2019		
Revisions		
3	ASI 01	4/21/2020
6	ASI 04	05/25/2020
9	ASI 07	12/15/2020
10	ASI 08	02/12/2021
11	ASI 09	02/26/2021
13	ASI 11	04/09/2021

56-18107-00
ENLARGED PLAN
THEATER MAIN
LEVEL